


**SCHEMATIC LANDSCAPE PLAN - FOR PRICING**  
05.01.2015

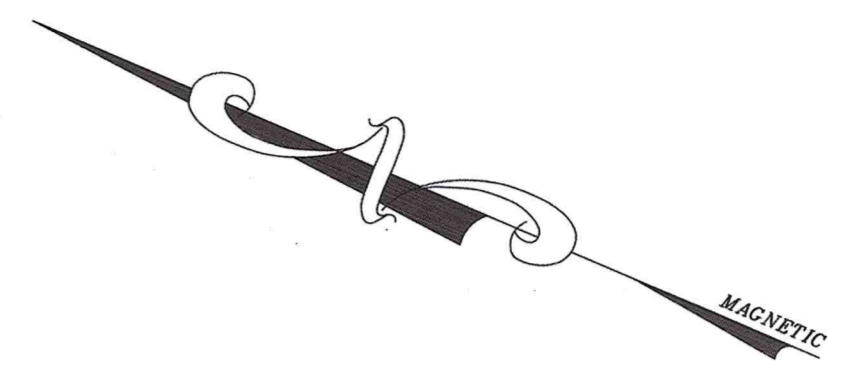

REV.	DATE	DESCRIPTION	BY

1438 SOUTH BROWNELL ROAD  
WILLISTON, VERMONT 05495  
PHONE: (802) 862-7588  
FAX: (802) 862-7588

**GREEN MOUNTAIN ENGINEERING**  
CIVIL  
WATER  
WASTEWATER

**DRAFT**

**CUSHMAN DESIGN GROUP**

P.O. BOX 855, 100 MOUNTAIN RD. STOWE, VT 05672  
TEL. 802.253.2189 FAX 802.253.2180  
www.cushmananddesign.com

<b>SITE PLAN</b>	BRISTOL FIRE HOUSE BRISTOL, VERMONT	CLIENT STONE HILL PROPERTIES
------------------	--	---------------------------------

DESIGNED AH	DATE 04/24/15
DRAWN RSO	SCALE 1" = 20'
CHECKED AH	DATE APR 2015
PROJECT NO. 25-010	
DRAWING NO. 1	
SHEET 1 OF XXX	